



PLAN
SCALE 1:100

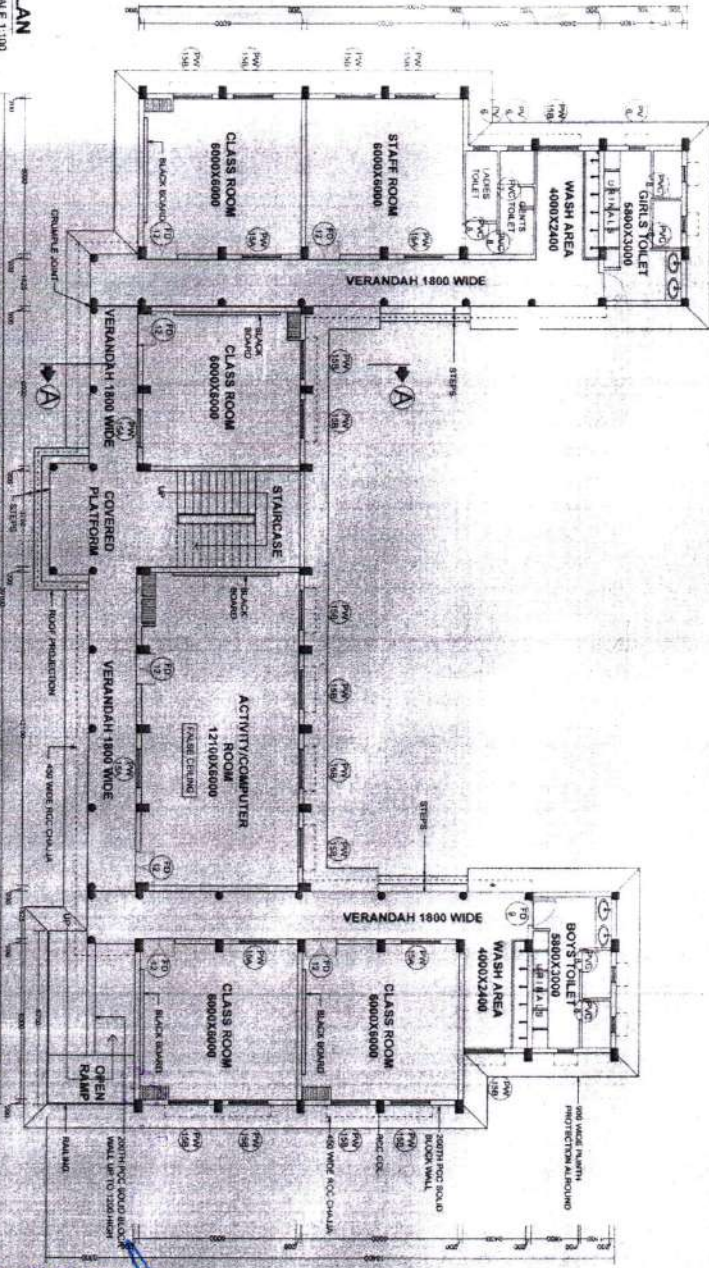

ROOF PLAN
SCALE 1:100

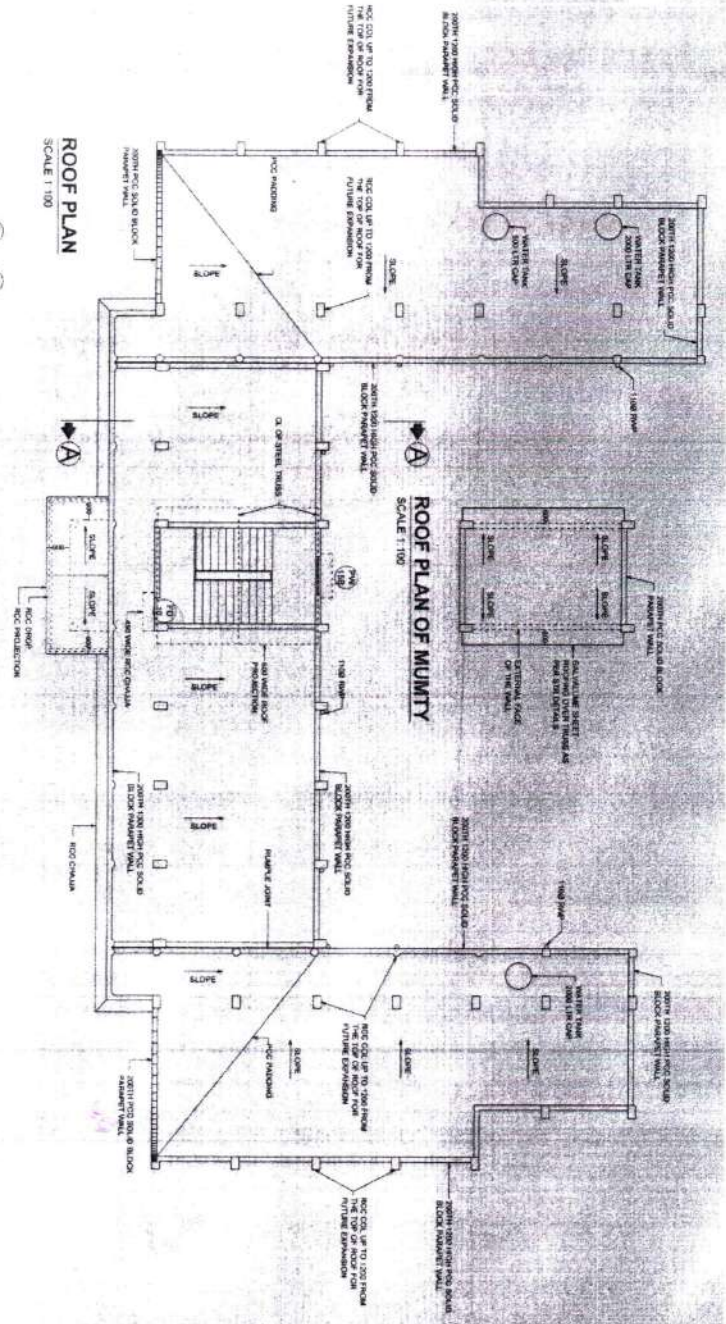

Chief Administrative Officer

Chief Administrative Officer
Sulur
Garrison Engineer


Digitally signed by Ron
Date: 2023.06.29 14:50:55 +05:30
Reason: reason
Location: location

PROVN OF INFRASTRUCTURE FOR AIR FORCE SCHOOL AT AF STN SULLUR	
PLANS	BLDG. NO. P - 635
DATE : 28 APR 2013	GARRISON ENGINEER
DRN - SM A ROY	AIR FORCE
TCD	SULLUR
CXD	
SCALE - AS SHOWN	REF. DRG NO. RD - 15
TECH. OFFICER	
AGE B/R-1	GARRISON ENGINEER
	(AP) SULLUR

- NOTES:-
1. CONTRACTOR TO CHECK AND VERIFY ALL THE DIMENSIONS BEFORE EXECUTION OF THE WORK.
 2. ALL DIMENSIONS ARE GIVEN IN MILLIMETERS UNLESS OTHERWISE SPECIFIED.
 3. FIGURED DIMENSIONS SHALL BE FOLLOWED.
 4. THIS DRAWING IS PREPARED BY CHIEF ENGINEER AIR FORCE BANGALORE NEP, DRG. NO. AFW/04/2013, DATED 21.12.2013.

NOTE - THIS BUILDING IS DESIGNED FOR FUTURE EXPANSION OF 2 MORE FLOORS (G+2 STRUCTURE). THE LAYOUT OF THE FUTURE 2 FLOORS SHALL BE SAME AS THAT OF GROUND FLOOR PLAN AS STATED BY THE USER VIDE THEIR LETTER NO. 5 BRD/175880/WKS DATED 28 APR 2013.

LAYOUT OF BUILDING No. P-543
AIR FORCE SCHOOL - AF STN SULUR

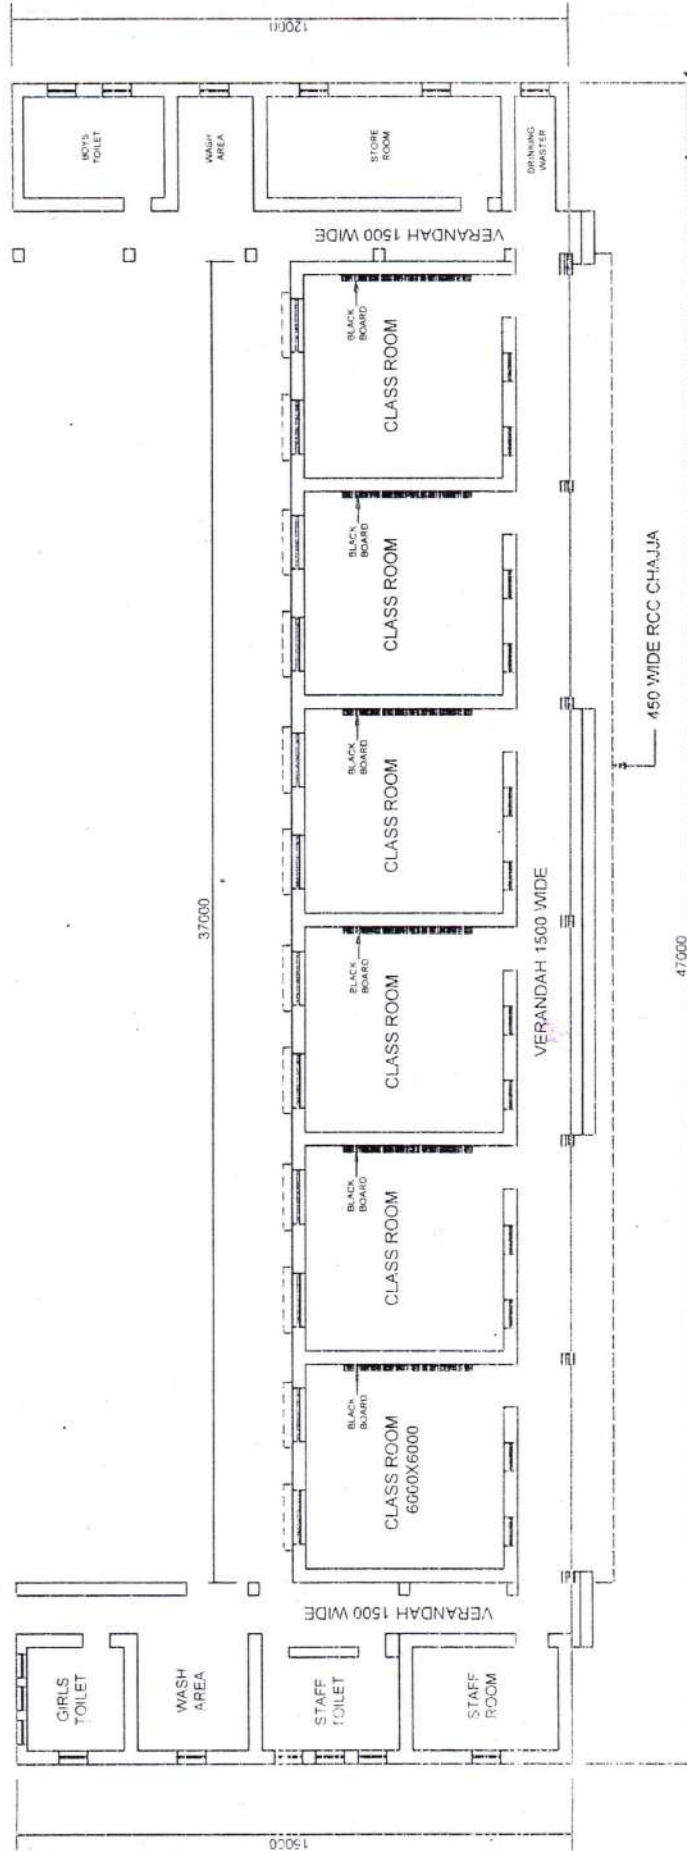

Air Force School Bldg

BLDG NO. P.		SHT NO.
DATE 30.4.12	GARRISON ENGINEER AIR FORCE SULUR	1/4
DRN - Ov A Key		
TCD		
CKD		
SCALE - AS SHOWN/REF DRG NO. RD.		
TECH OFFICER		GARRISON ENGINEER (AF) SULUR
AGE BR-I		




SCALE 1:1000

(Signature)
 (एन एम पिटर्स)
 (SM Peters)
 ग्रुप कैप्टन
 Group Captain
 मुख्य प्रशासनिक अधिकारी
 Chief Administrative Officer

प्रशासनिक अधिकारी
 Chief Administrative Officer

LAYOUT OF BUILDING No. P-135
AIR FORCE SCHOOL - AF STN SULUR

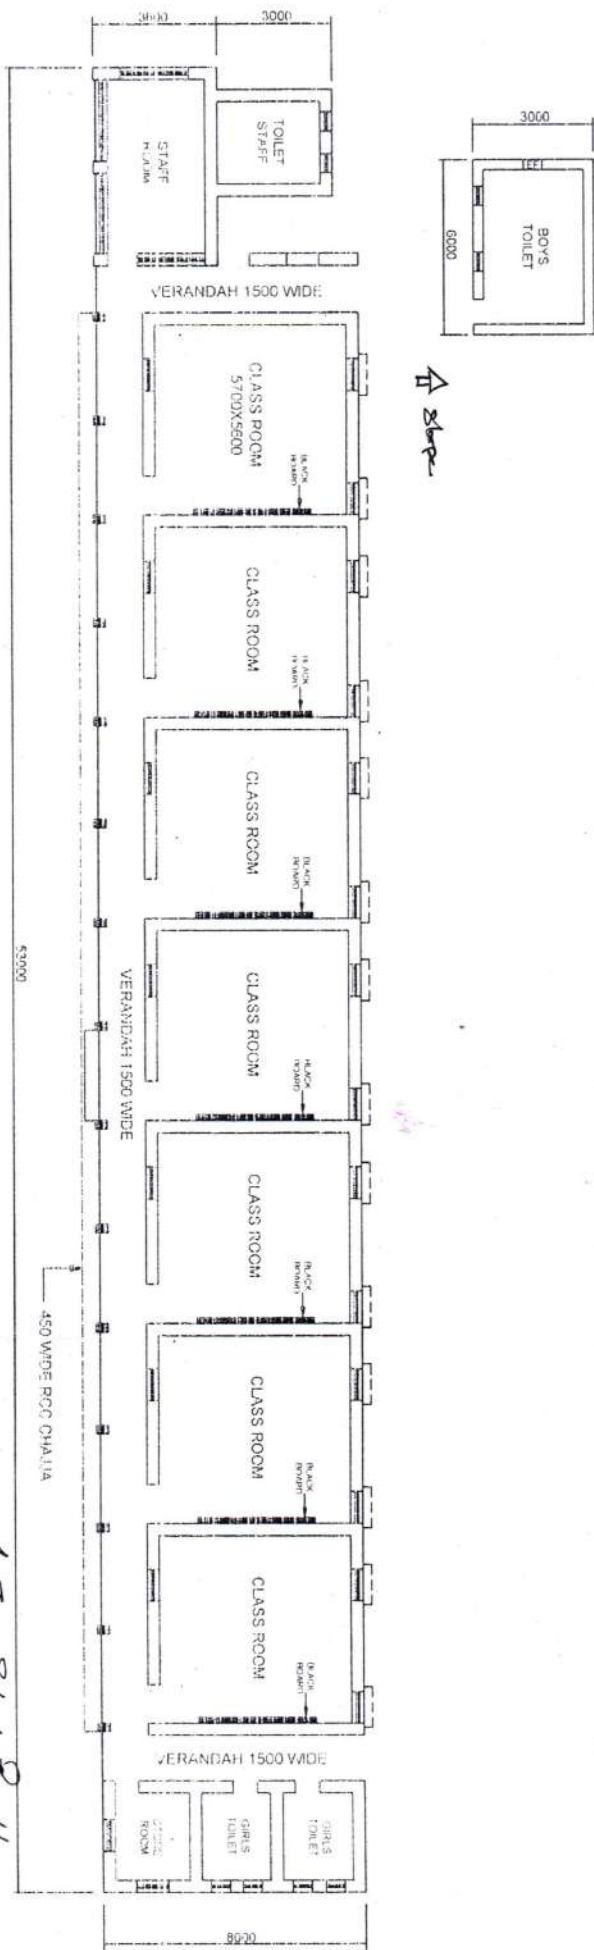

SCALE
1 : 100

(रस पट्टि)
(SM Peters)
ग्रुप कैप्टन
Group Captain

(रस पट्टि)
(SM Peters)
ग्रुप कैप्टन
Group Captain

Chief Administrative Officer

Chief Administrative Officer

Chief Administrative Officer

Air Force School Building

Ground Floor ONLY.

BLDG NO. P -		GARRISON ENGINEER AIR FORCE SULUR	
DATE	30.04.12	DRN - CIV A KRISH	1/4
TCD	-	CKD	✓
SCALE - AS SHOWN/REF DRG NO RD - 29		GARRISON ENGINEER AIR FORCE SULUR	
TECH OFFICER		GARRISON ENGINEER AIR FORCE SULUR	